


#	REVISION	DATE

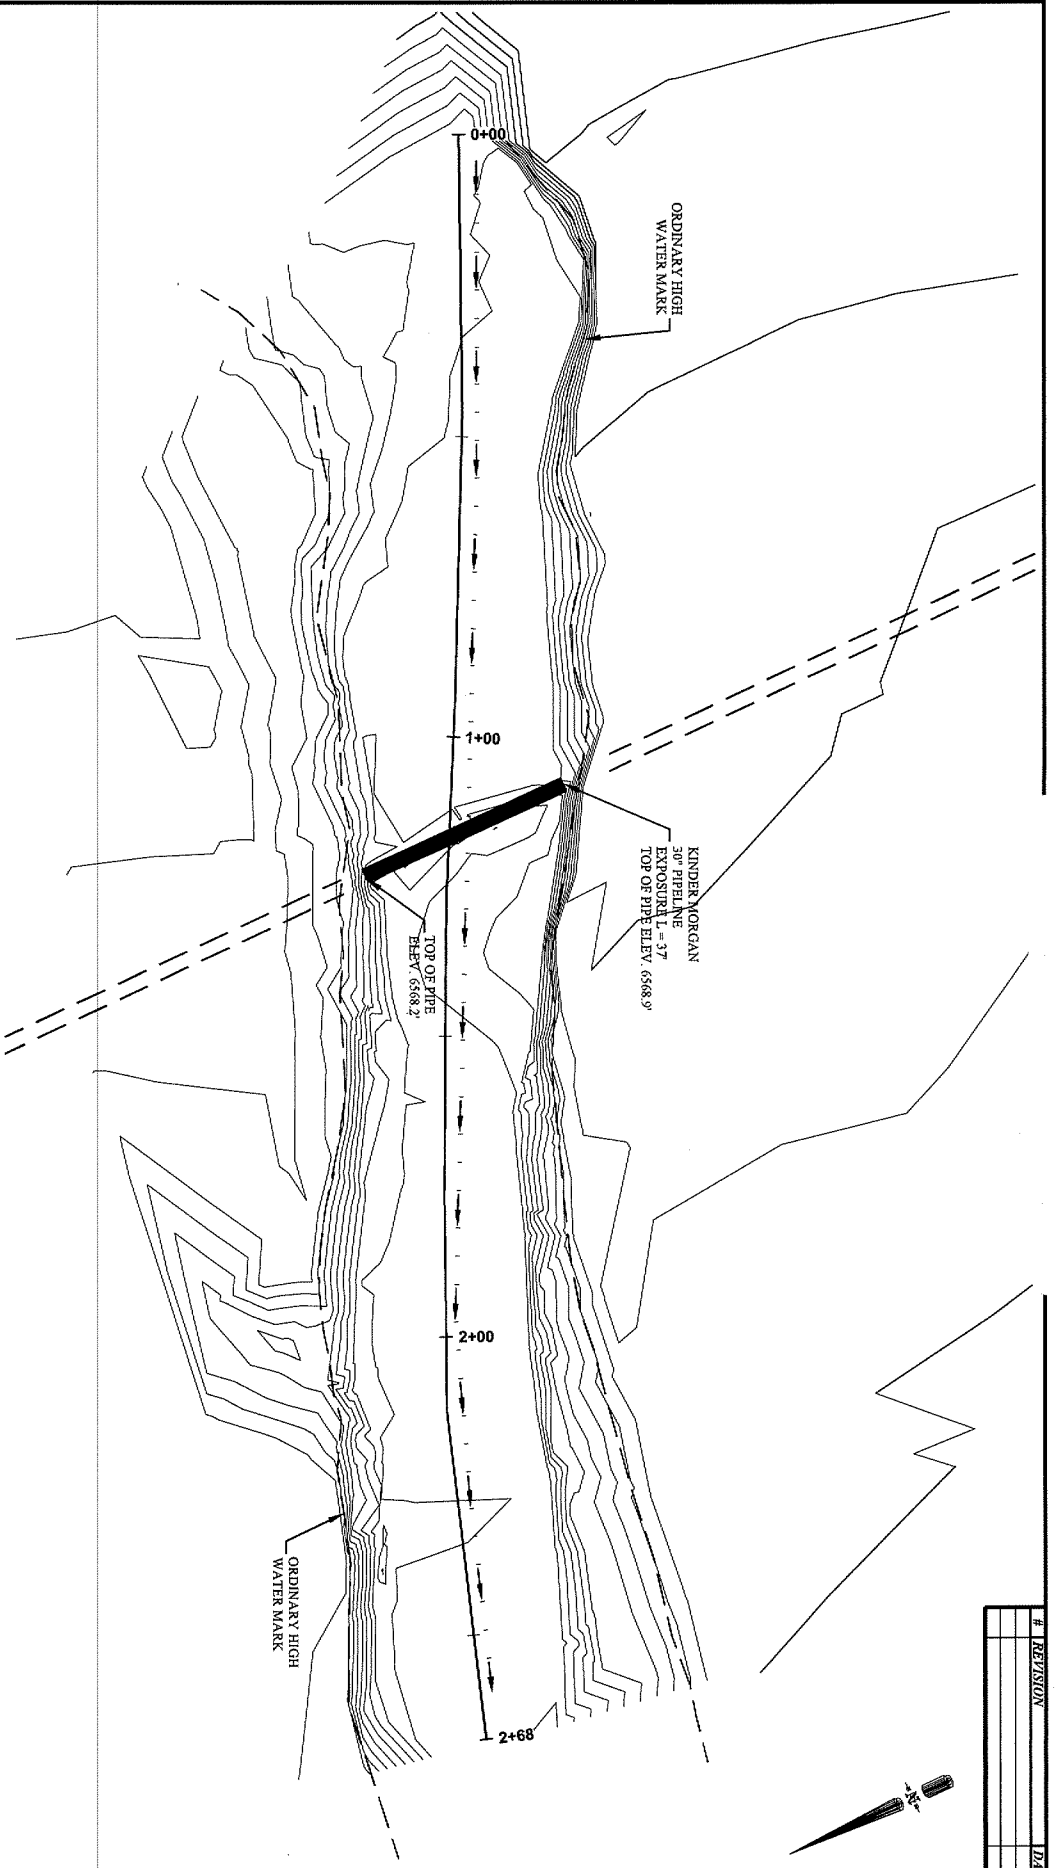



805 Dunn Street
Houston, TX 77060
Tel: 281-461-4900
Fax: 281-461-0108
Email: submar@submar.com
Website: www.submar.com

UNNAMED WASH
SAN JUAN COUNTY
BLOOMFIELD, NM

EXISTING
CONDITIONS



LEGEND:
— EXPOSED PIPELINE
--- BURIED PIPELINE
--- FLOW LINES

THESE CONCEPTUAL DRAWINGS ARE PREPARED BY SUBMAR FOR ESTIMATING PURPOSES ONLY AND ARE NOT CONSTRUCTION DRAWINGS. THESE CONFIDENTIAL DRAWINGS MUST NOT BE COPIED UNLESS APPROVED BY SUBMAR, INC.

COPYRIGHT © SUBMAR, INC. 2013. ALL RIGHTS RESERVED.	DATE: 12/30/13	SHEET: 1 of 5	SCALE: 1" = 20'	PROJECT #: 12563	DRAWING #: C-101	DWN BY: AUP	CKD BY: BAC	CONTACT: STEVE BROWN	PHONE: 505-867-1320
--	-------------------	------------------	--------------------	---------------------	---------------------	----------------	----------------	-------------------------	------------------------



805 Dunn Street
Houma, LA 70360
Ph. 985-868-0001
Fax 985-851-0108
Email: submar@submar.com
Website: www.submar.com

UNNAMED WASH
SAN JUAN COUNTY
BLOOMFIELD, NM

**PROPOSED SITE
GRADING PLAN**

KINDER MORGAN
ENERGY PARTNERS, L.P.

 EXPOSED PIPELINE
 BURIED PIPELINE
 FLOW LINES

THESE CONCEPTUAL DRAWINGS ARE PREPARED BY SUBMAR FOR ESTIMATING PURPOSES ONLY AND ARE NOT CONSTRUCTION DRAWINGS. THESE CONFIDENTIAL DRAWINGS MAY NOT BE COPIED UNLESS APPROVED BY SUBMAR, INC.

**COPYRIGHT © SUBMAR, INC.
2013 ALL RIGHTS RESERVED.**

DATE:
12/30/13

SHEET
2 of 5

SCAL
 $I'' = 2$

PROJECT #:
12563

DRAWING #:
C-102

DWV
ML


**CKD BY
BAC**

CONTACT:
STEVE BROWN

PHONE:
505-867-1320

GPS: N36.34807°
W107.73277°

#	REVISION	DATE

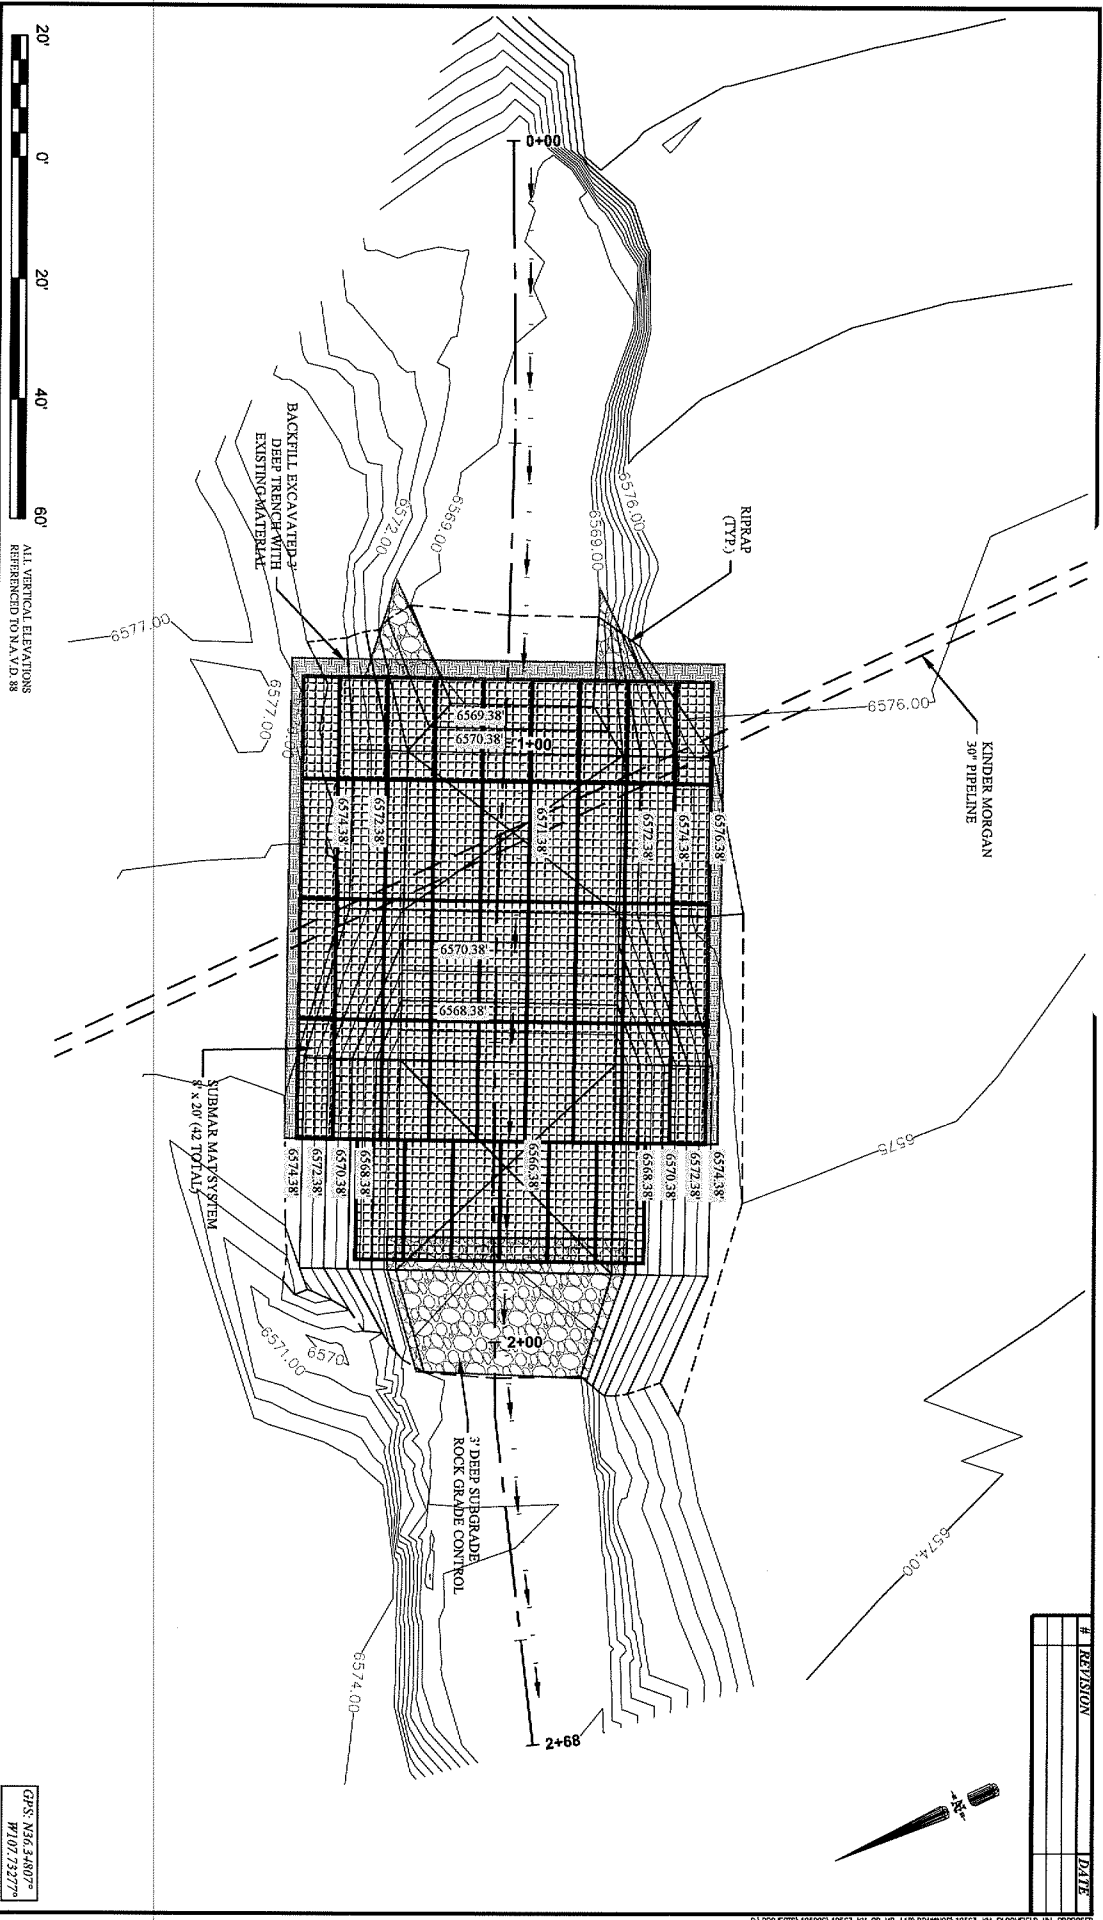



805 Duna Street
Houma, LA 70360
P: 806-461-4000
Email: submar@submar.com
Website: www.submar.com

UNNAMED WASH
SAN JUAN COUNTY
BLOOMFIELD, NM

PROPOSED SUBMAR
MAT ARMORMENT PLAN

KINDER MORGAN
ENERGY PARTNERS, L.P.



DATE: 12/30/13
SHEET: 3 of 3
SCALE: 1" = 20'
PROJECT #: 12363
DRAWING #: C-103
DWN BY: MJP
CND BY: BAC
CONTACT: STEVE BROHNY
PHONE: 505-867-1320

LEGEND:
EXPOSED PIPELINE
BURIED PIPELINE
FLOW LINES

GPS: N66.4407°
W107.7327°

THESE CONCEPTUAL DRAWINGS ARE PREPARED BY SUBMAR FOR ESTIMATING PURPOSES ONLY AND ARE NOT CONSTRUCTION DRAWINGS. THESE CONCEPTUAL DRAWINGS MAY NOT BE COPIED UNLESS APPROVED BY SUBMAR, INC.

#	REVISION	DATE

 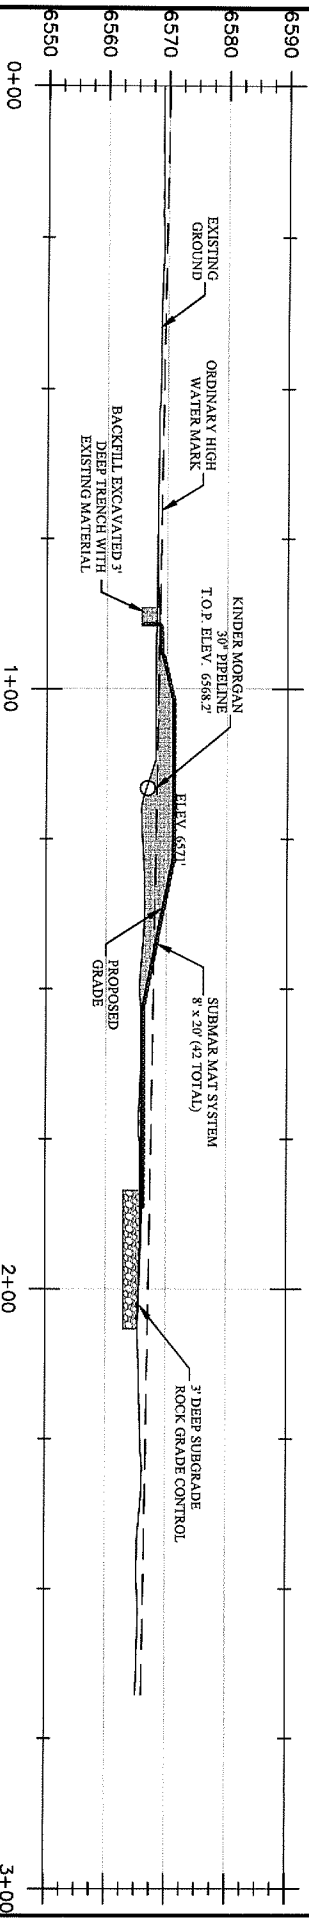



305 Duna Street
Bloomington, LA 78840
P: 805-867-4000
E: submar@submar.com
W: www.submar.com

UNNAMED WASH
SAN JUAN COUNTY
BLOOMFIELD, NM

KINDER MORGAN
ENERGY PARTNERS, L.P.

THESE CONCEPTUAL DRAWINGS ARE PREPARED BY SUBMAR FOR ESTIMATING PURPOSES ONLY AND ARE NOT CONSTRUCTION DRAWINGS. THESE CONFIDENTIAL DRAWINGS MAY NOT BE COPIED UNLESS APPROVED BY SUBMAR, INC.

COPYRIGHT © SUBMAR, INC.
2011 ALL RIGHTS RESERVED.

DATE: 12/30/13
SHEET: 4 of 5
SCALE: 1" = 20'

PROJECT #: 13563
DRAWING #: C-104
DWG BY: AJP
CND BY: BMC



CONTACT: STEVE BROHMY
PHONE: 505-867-1320

LEGEND:

- EXPOSED PIPELINE
- BURIED PIPELINE
- FLOW LINES
- PROPOSED FILL
- PROPOSED CUT

GPS: N36.34807°
W107.73277°

#	REVISION	DATE

 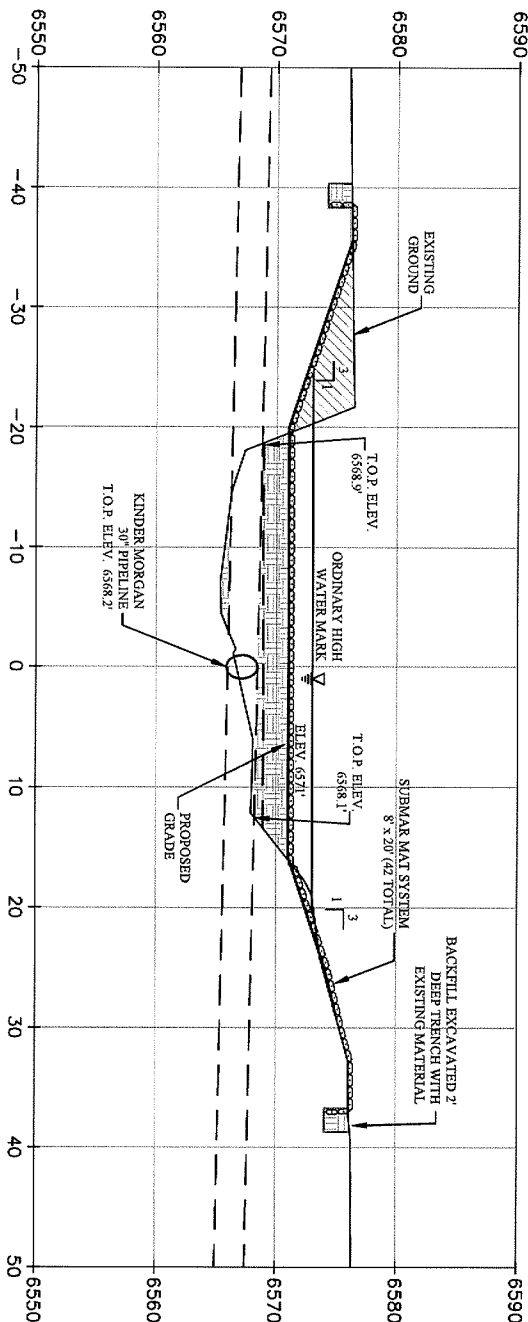

805 Dana Street
Houston, TX 77060
Tel: 281-461-4008
Email: submar@submar.com
Website: www.submar.com

THESE CONCEPTUAL DRAWINGS ARE PREPARED BY SUBMAR FOR ESTIMATING PURPOSES ONLY AND ARE NOT CONSTRUCTION DRAWINGS. THESE CONFIDENTIAL DRAWINGS MAY NOT BE COPIED UNLESS APPROVED BY SUBMAR, INC.

UNNAMED WASH
SAN JUAN COUNTY
BLOOMFIELD, NM

SHEET TITLE:

CROSS SECTION



COPYRIGHT © SUBMAR, INC.	DATE:	SHEET:	SCALE:	PROJECT #:	DRAWING #:	DWN BY:	CAD BY:	CONTACT:	PHONE:
2011 ALL RIGHTS RESERVED	12/30/13	5 of 3	1" = 10'	12563	C-105	MAP	BMC	STEVE BROWN	505-867-1320

LEGEND:

- EXPOSED PIPELINE
- BURIED PIPELINE
- FLOW LINES
- PROPOSED FILL
- PROPOSED CUT

GPS: N36.34807°
W107.73277°